


ANNEXURE C FLOOR PLAN

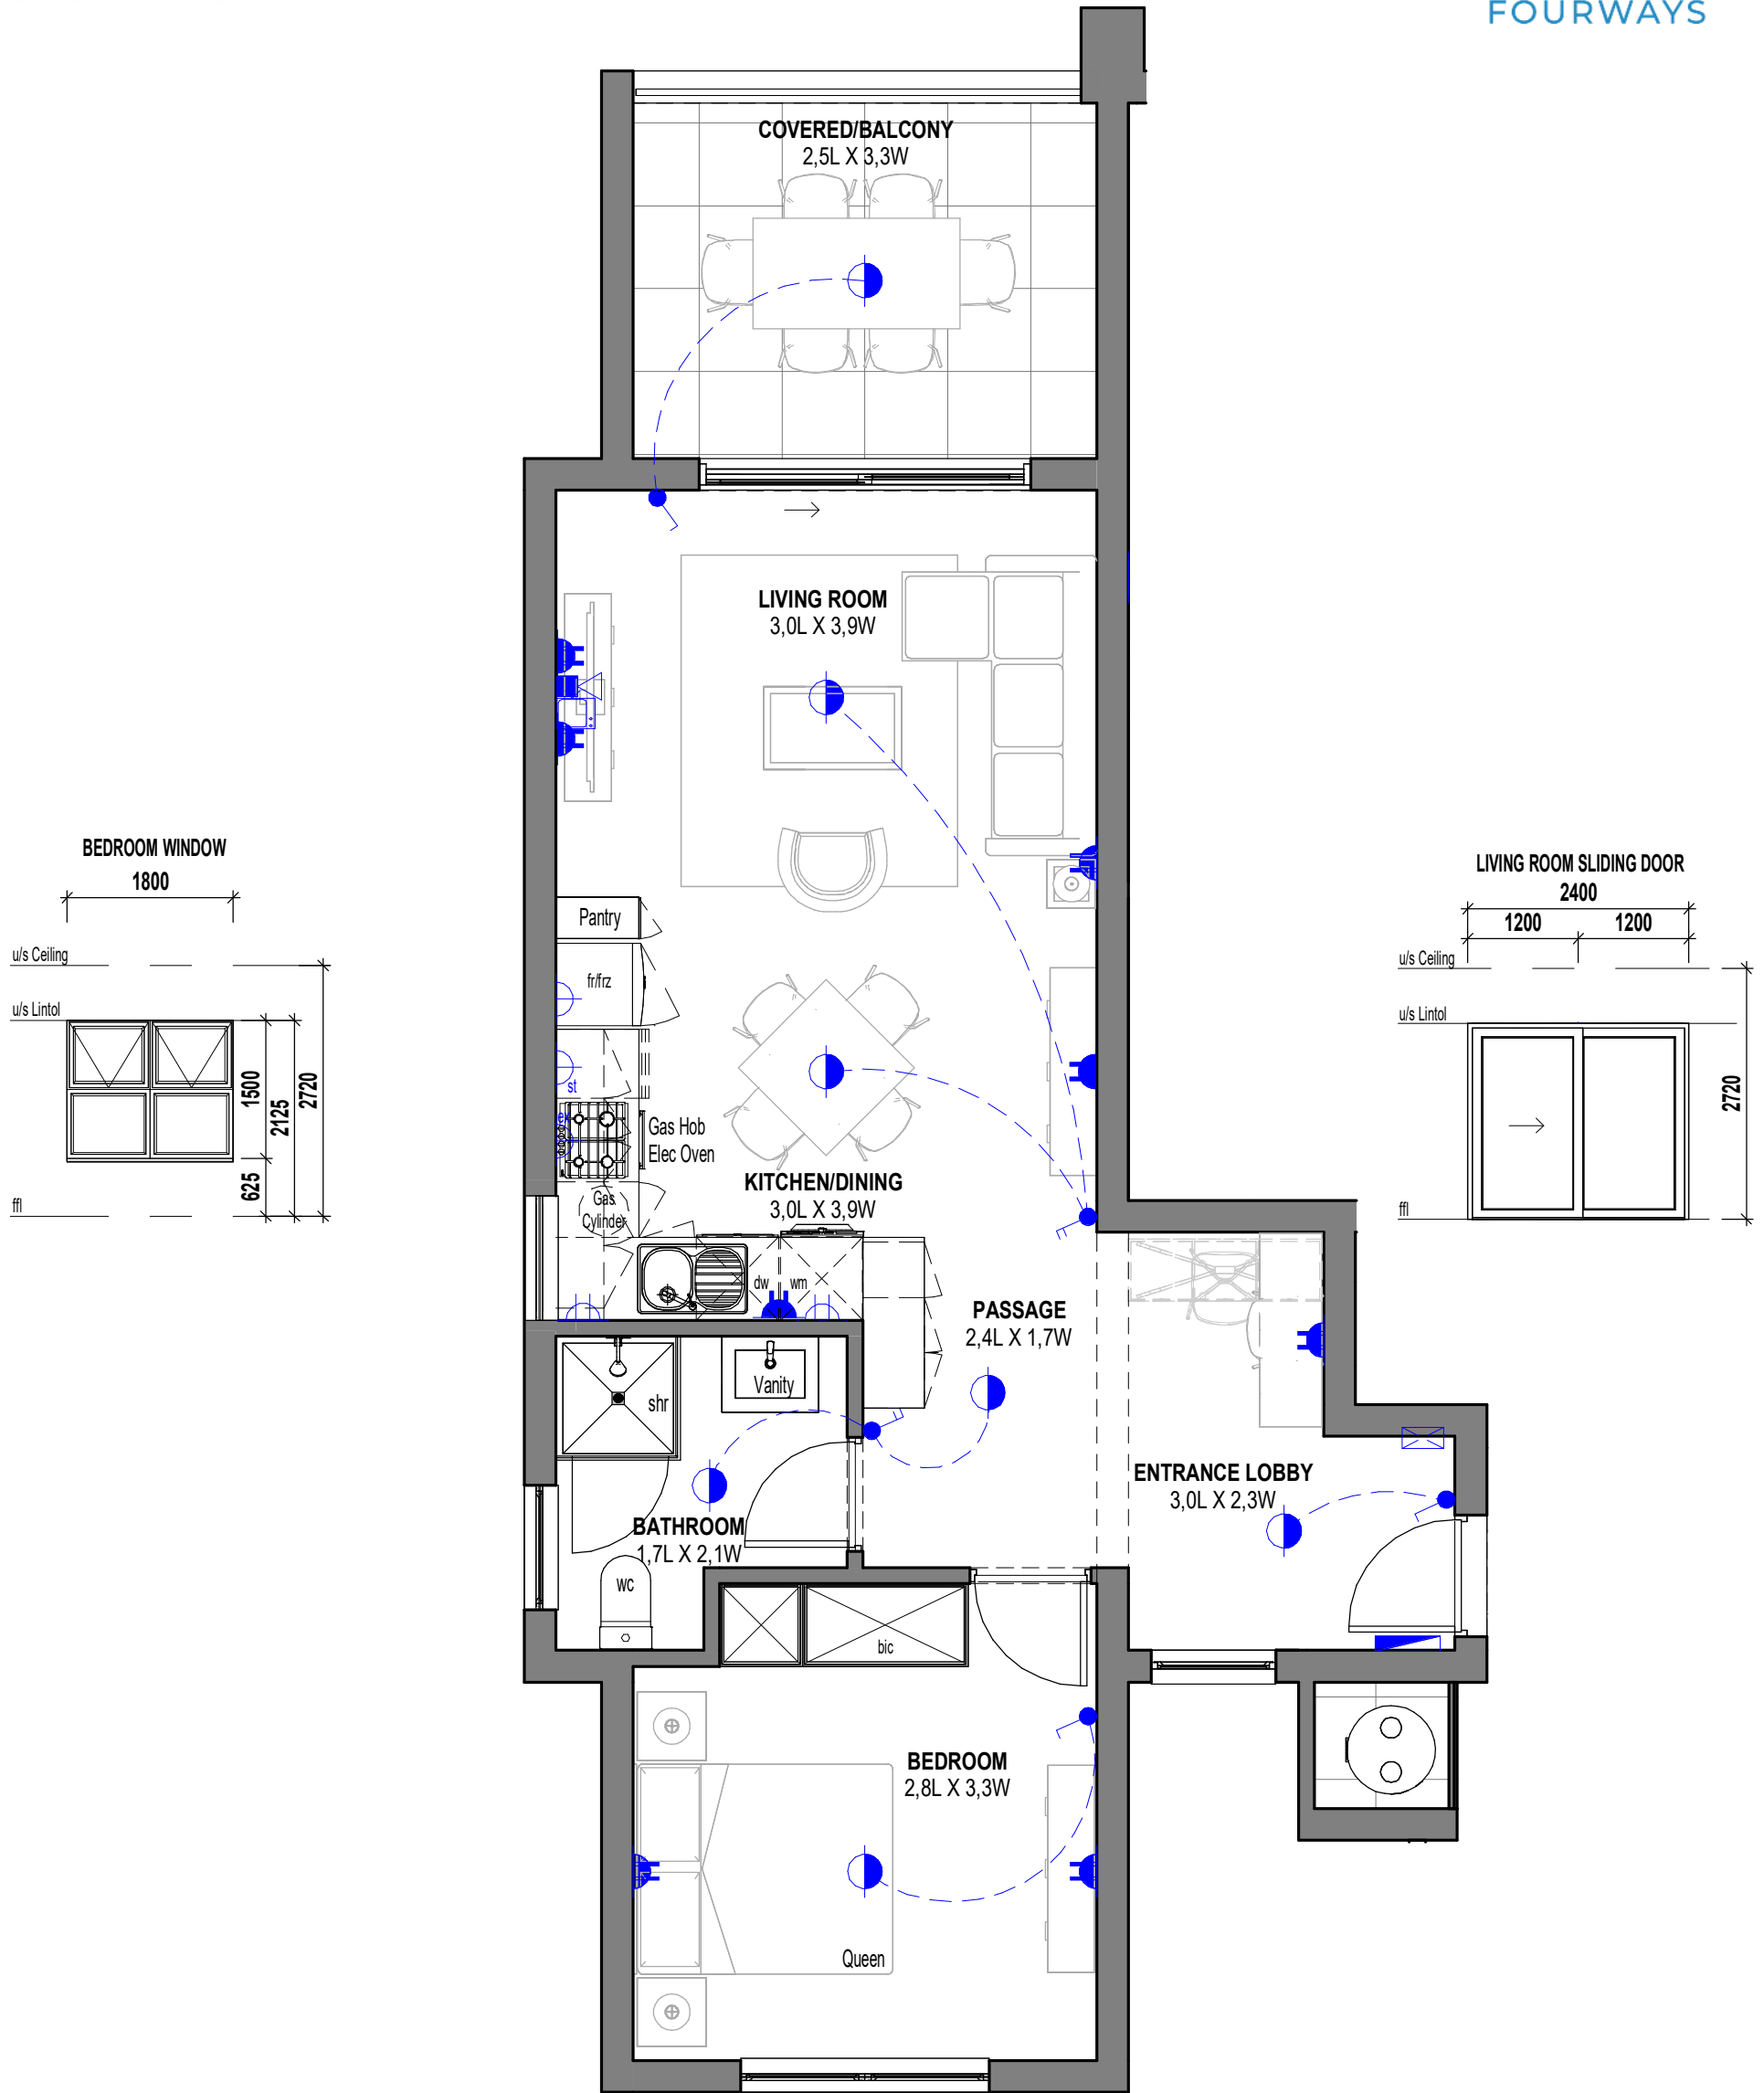

1 Bedroom - 1 Bathroom

SCALE 1:50

B2(B)

ELECTRICAL LEGEND

- Surface Mounted LED Fitting
- External Wall Mounted LED Light Fitting
- LED Strip Light Fitting (u/s - Eye levels - Kitchen)
- Single Light Switch
- Double Light Switch
- Triple Light Switch
- Two-Way Light Switch
- Single Plug Point (300mm Above FFL)
- Double Plug Point (300mm Above FFL)
- Single Plug Point (150mm Above Counter)
- Double Plug Point (150mm Above Counter)
- Stove Isolator (Above Counter)
- Extractor Plug (High Level)
- Distribution Board
- TV Point
- Fibre / Data Point
- Inverter

**AREA
TYPE B2(B)**

Floor Area	56.91 m ²
Cov Balcony	10.38 m ²
Total	67.29 m ²

* The areas are approximate and shall vary from the areas reflected on the sectional title plan